


MAIN LIBRARY
EXPANSION PROJECT

Massachusetts Public Library
Massachusetts

Exterior Entrance Electrical Plan

Massachusetts Public Library

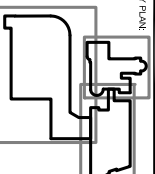

DRAWING TITLE: Exterior Electrical Plan

DATE: REVISION

DRAWN BY: JM


CHECKED BY: Phil Damann

SCALE: 1/8" = 1'-0"

DUE DATE: 4/17/09

DRAWING NUMBER:

E1

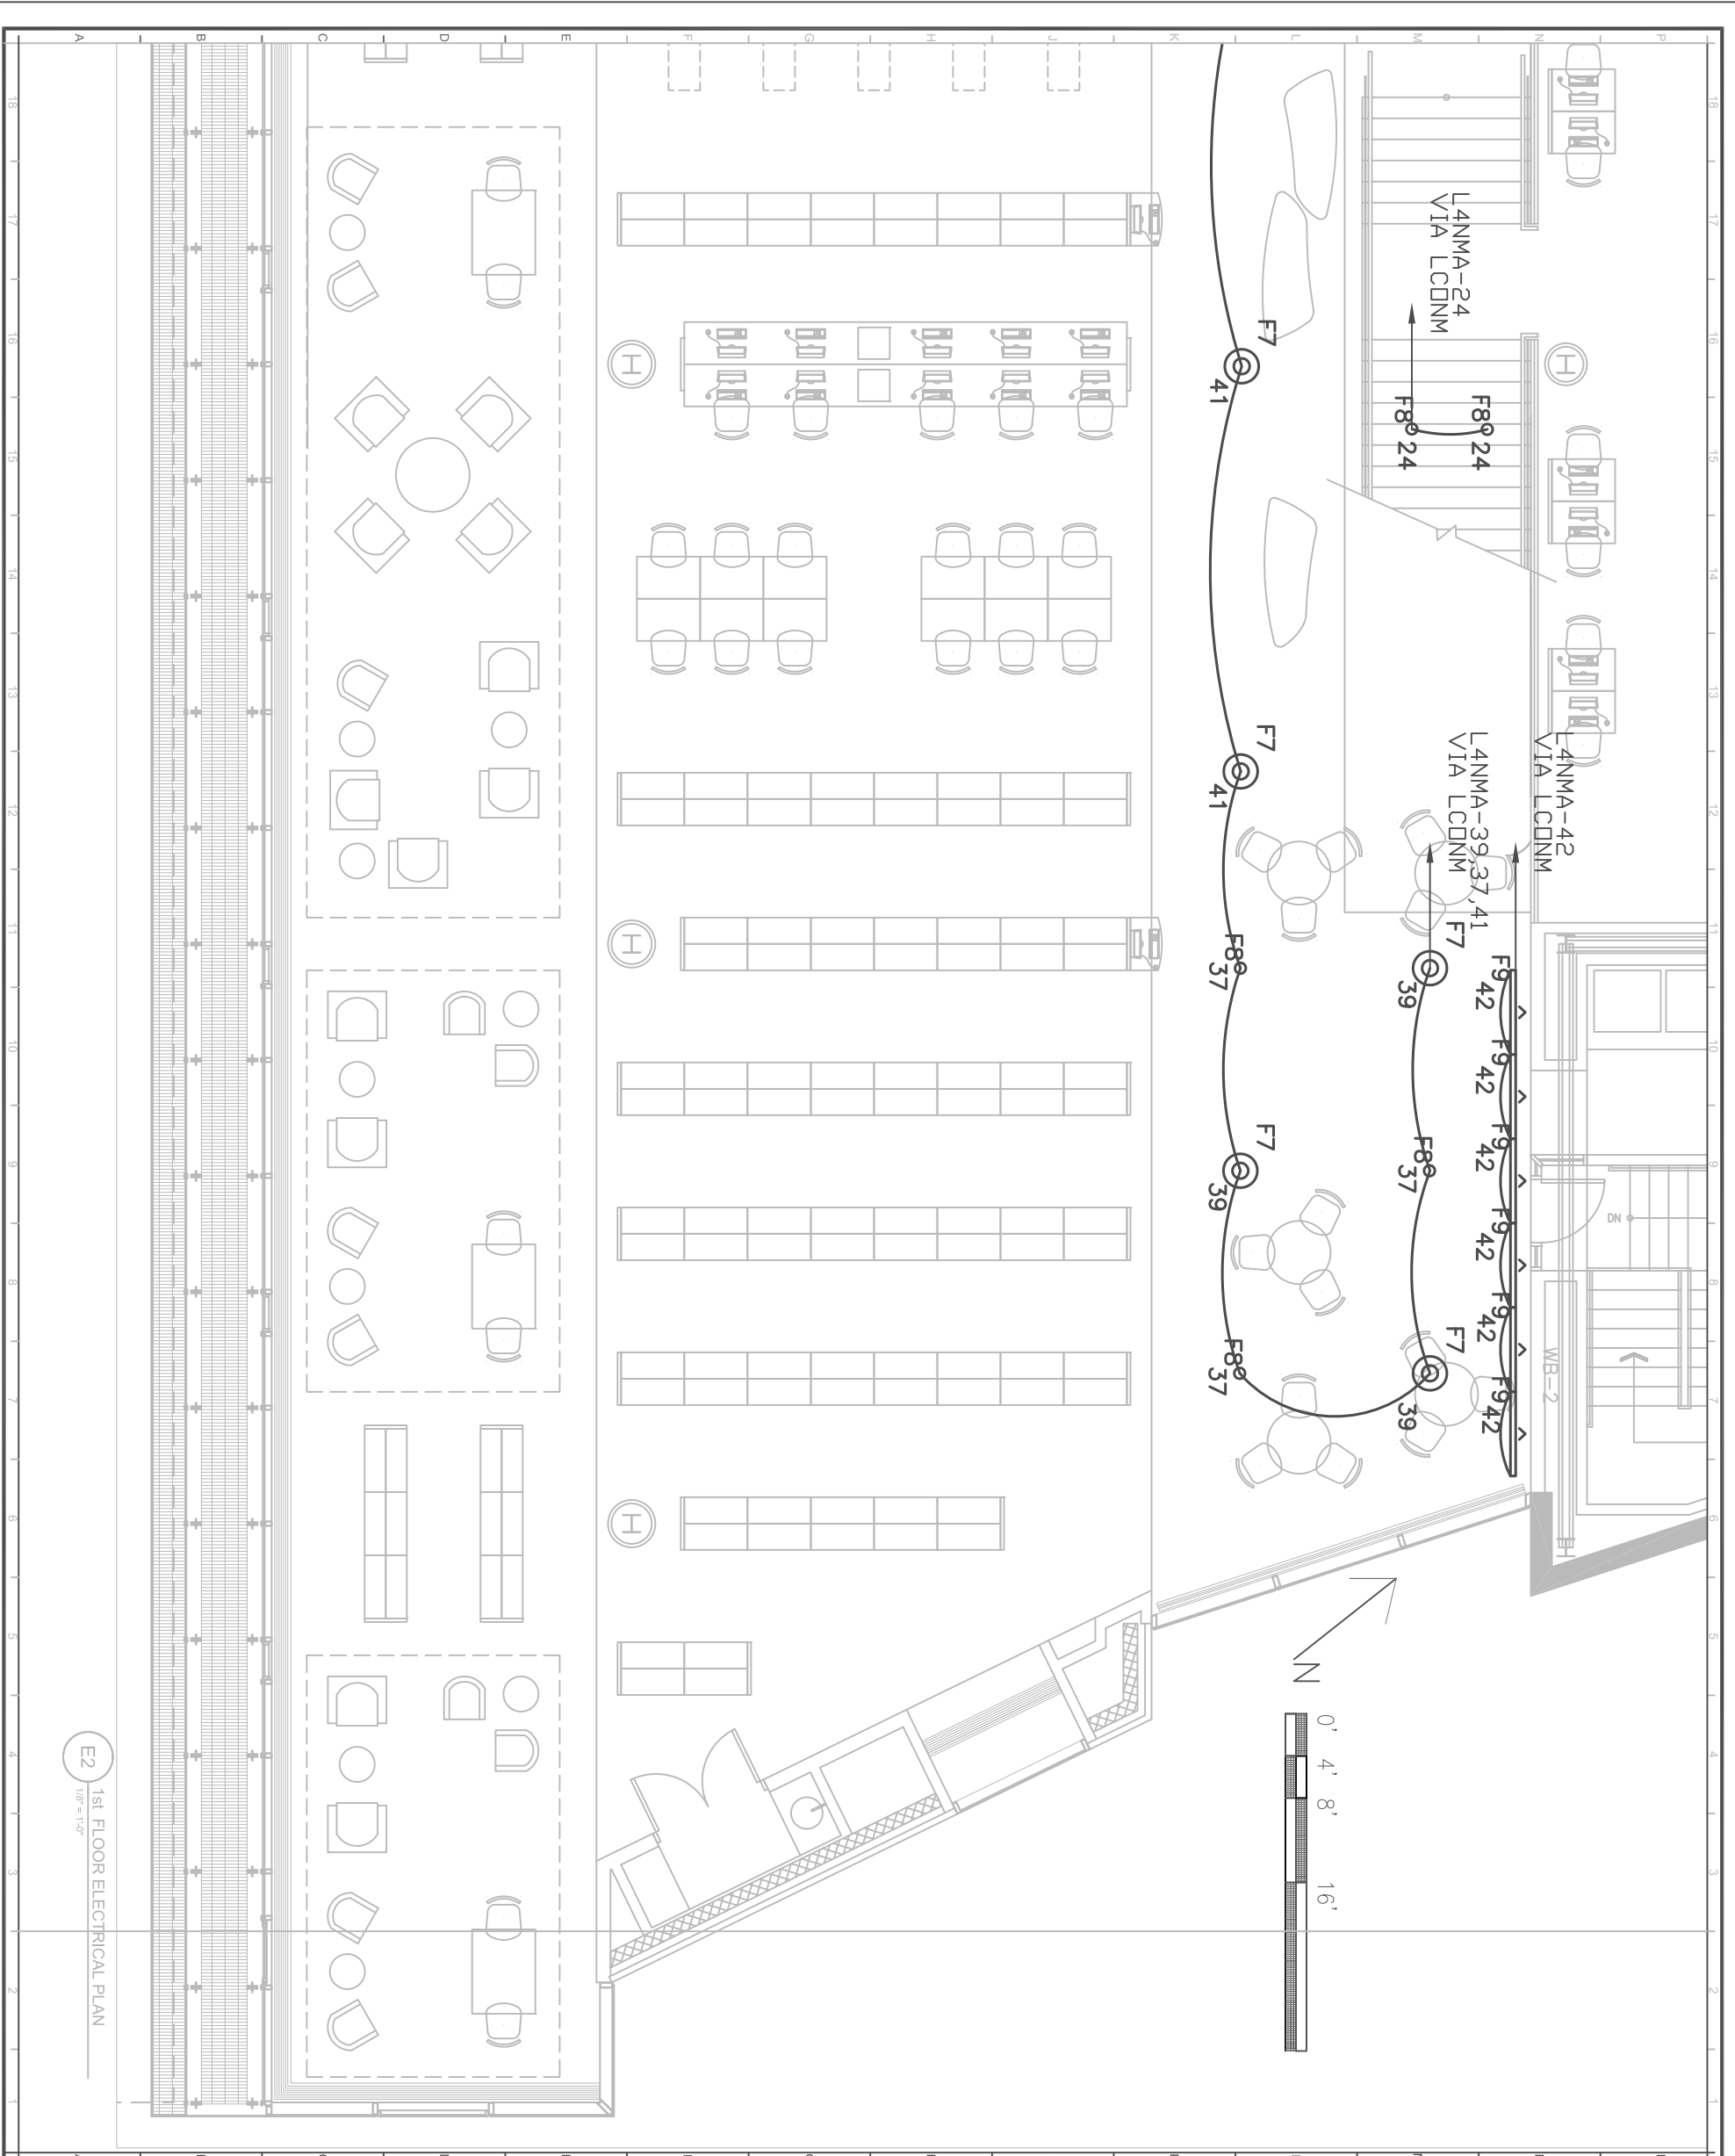


E2 1st FLOOR ELECTRICAL PLAN
1/8" = 1'-0"

Entry Lobby Electrical Plan

SCALE: 1/8"=1'0"

Massachusetts Public Library

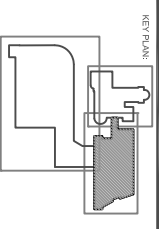

DRAWING TITLE
1st FLOOR ELECTRICAL PLAN

DATE: REVISION


DRAWN BY: Marisa Gaud
CHECKED BY: Paul Demerth

SCALE: 1/8" = 1'-0"

DATE: 4/7/09

DRAWING NUMBER

E2-B

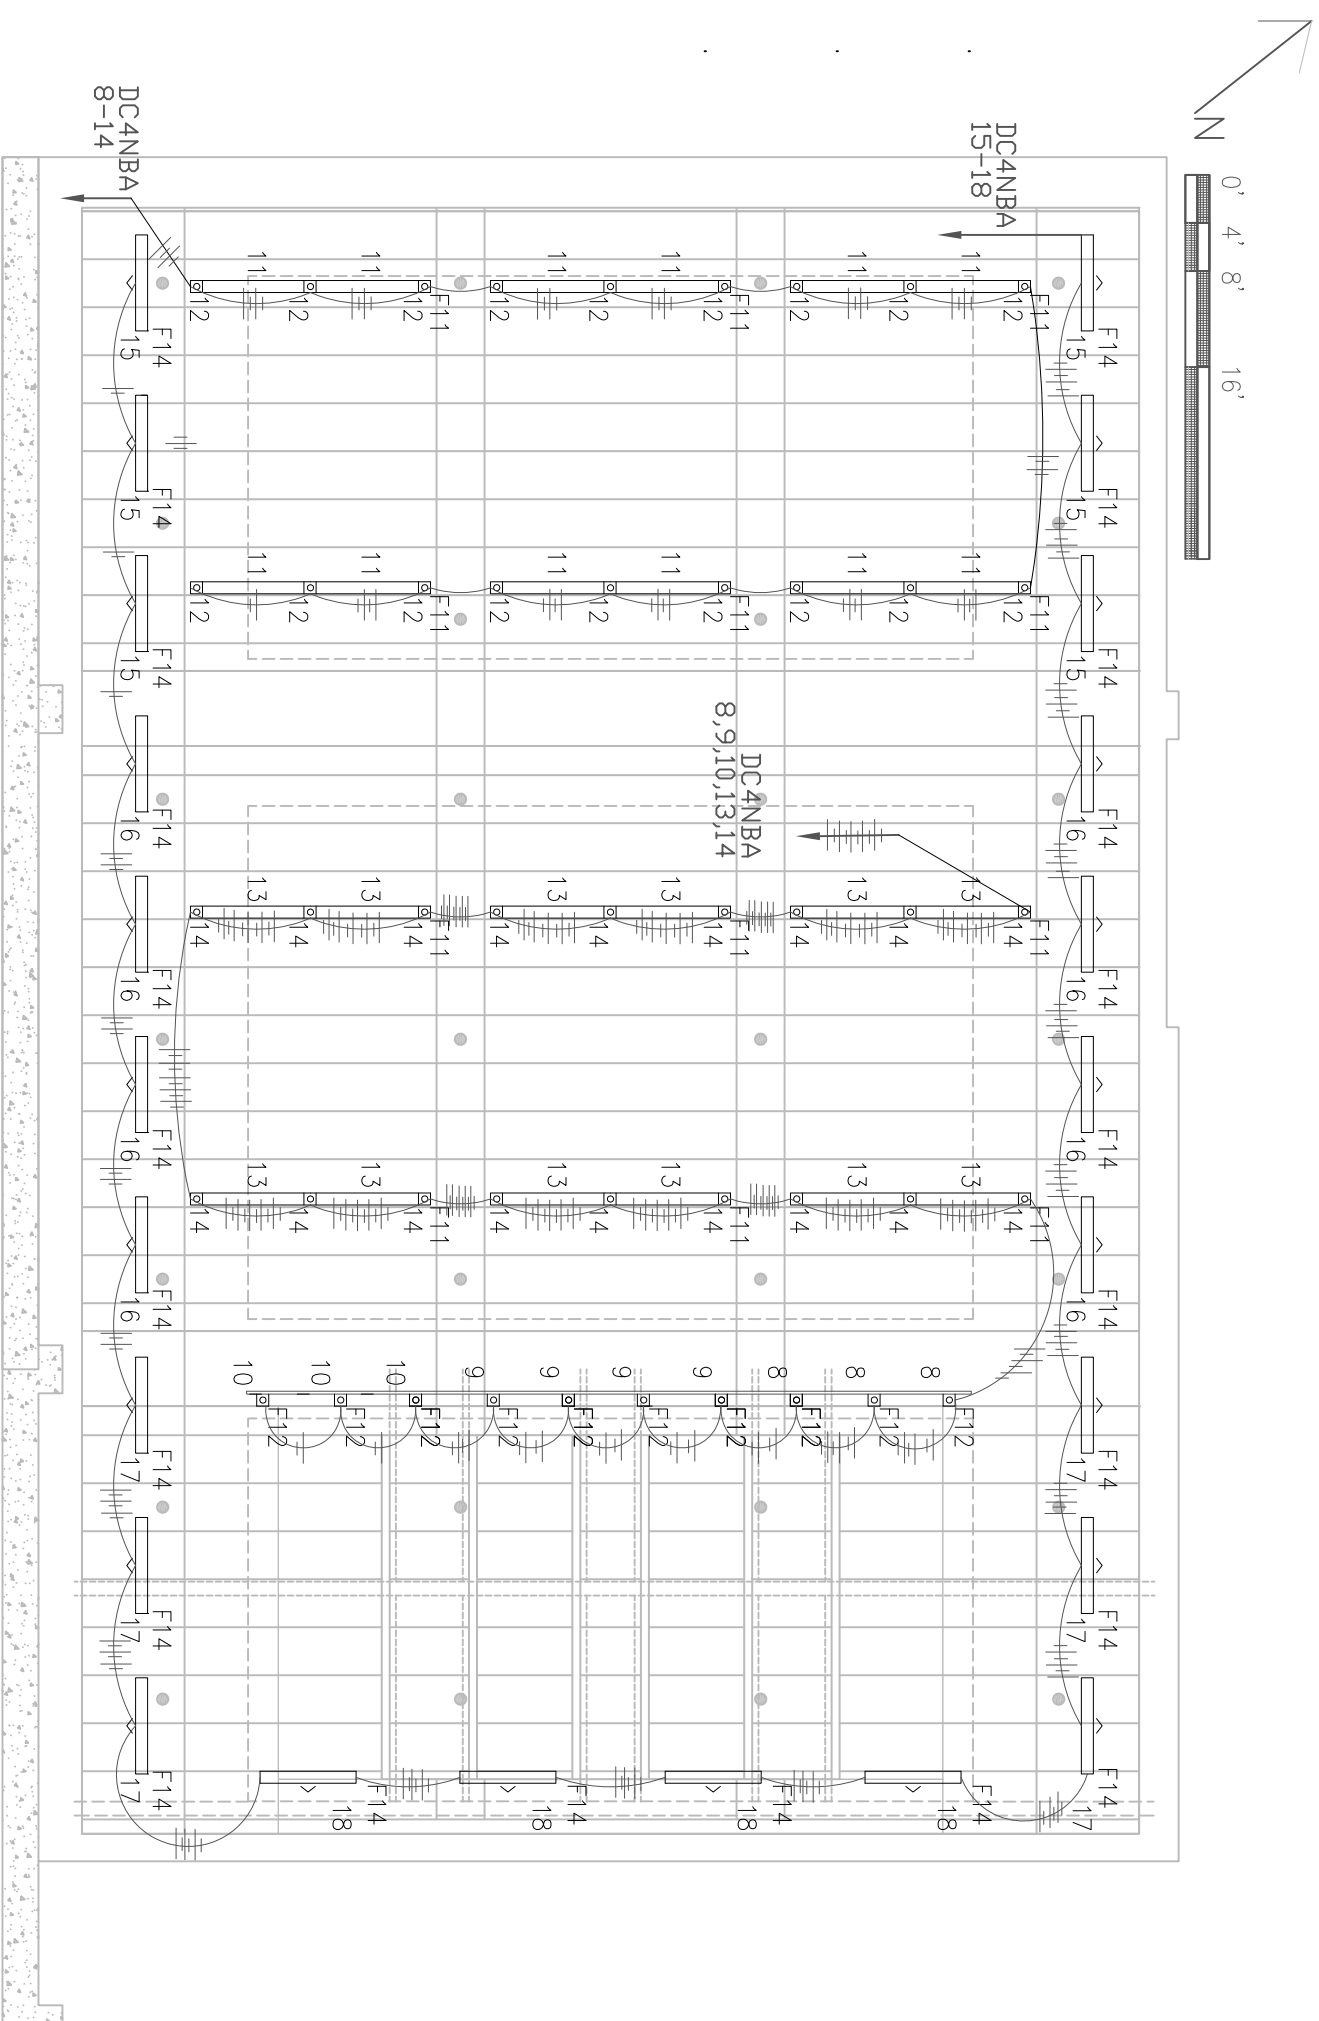


MAIN LIBRARY
EXPANSION PROJECT

Massachusetts Public Library
Thesis Project

Meeting Room Electrical Plan

SCALE: 1/8"=1'0"

Massachusetts Public Library

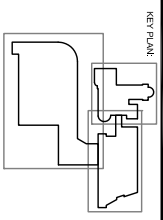

DRAWING TITLE
MEETING ROOM ELECTRICAL PLAN

DATE: _____

DATE: _____



DATE: _____

DATE: _____

DATE: _____

E3 ENLARGED REFLECTED CEILING PLAN
1/8"=1'-0"

E3-A

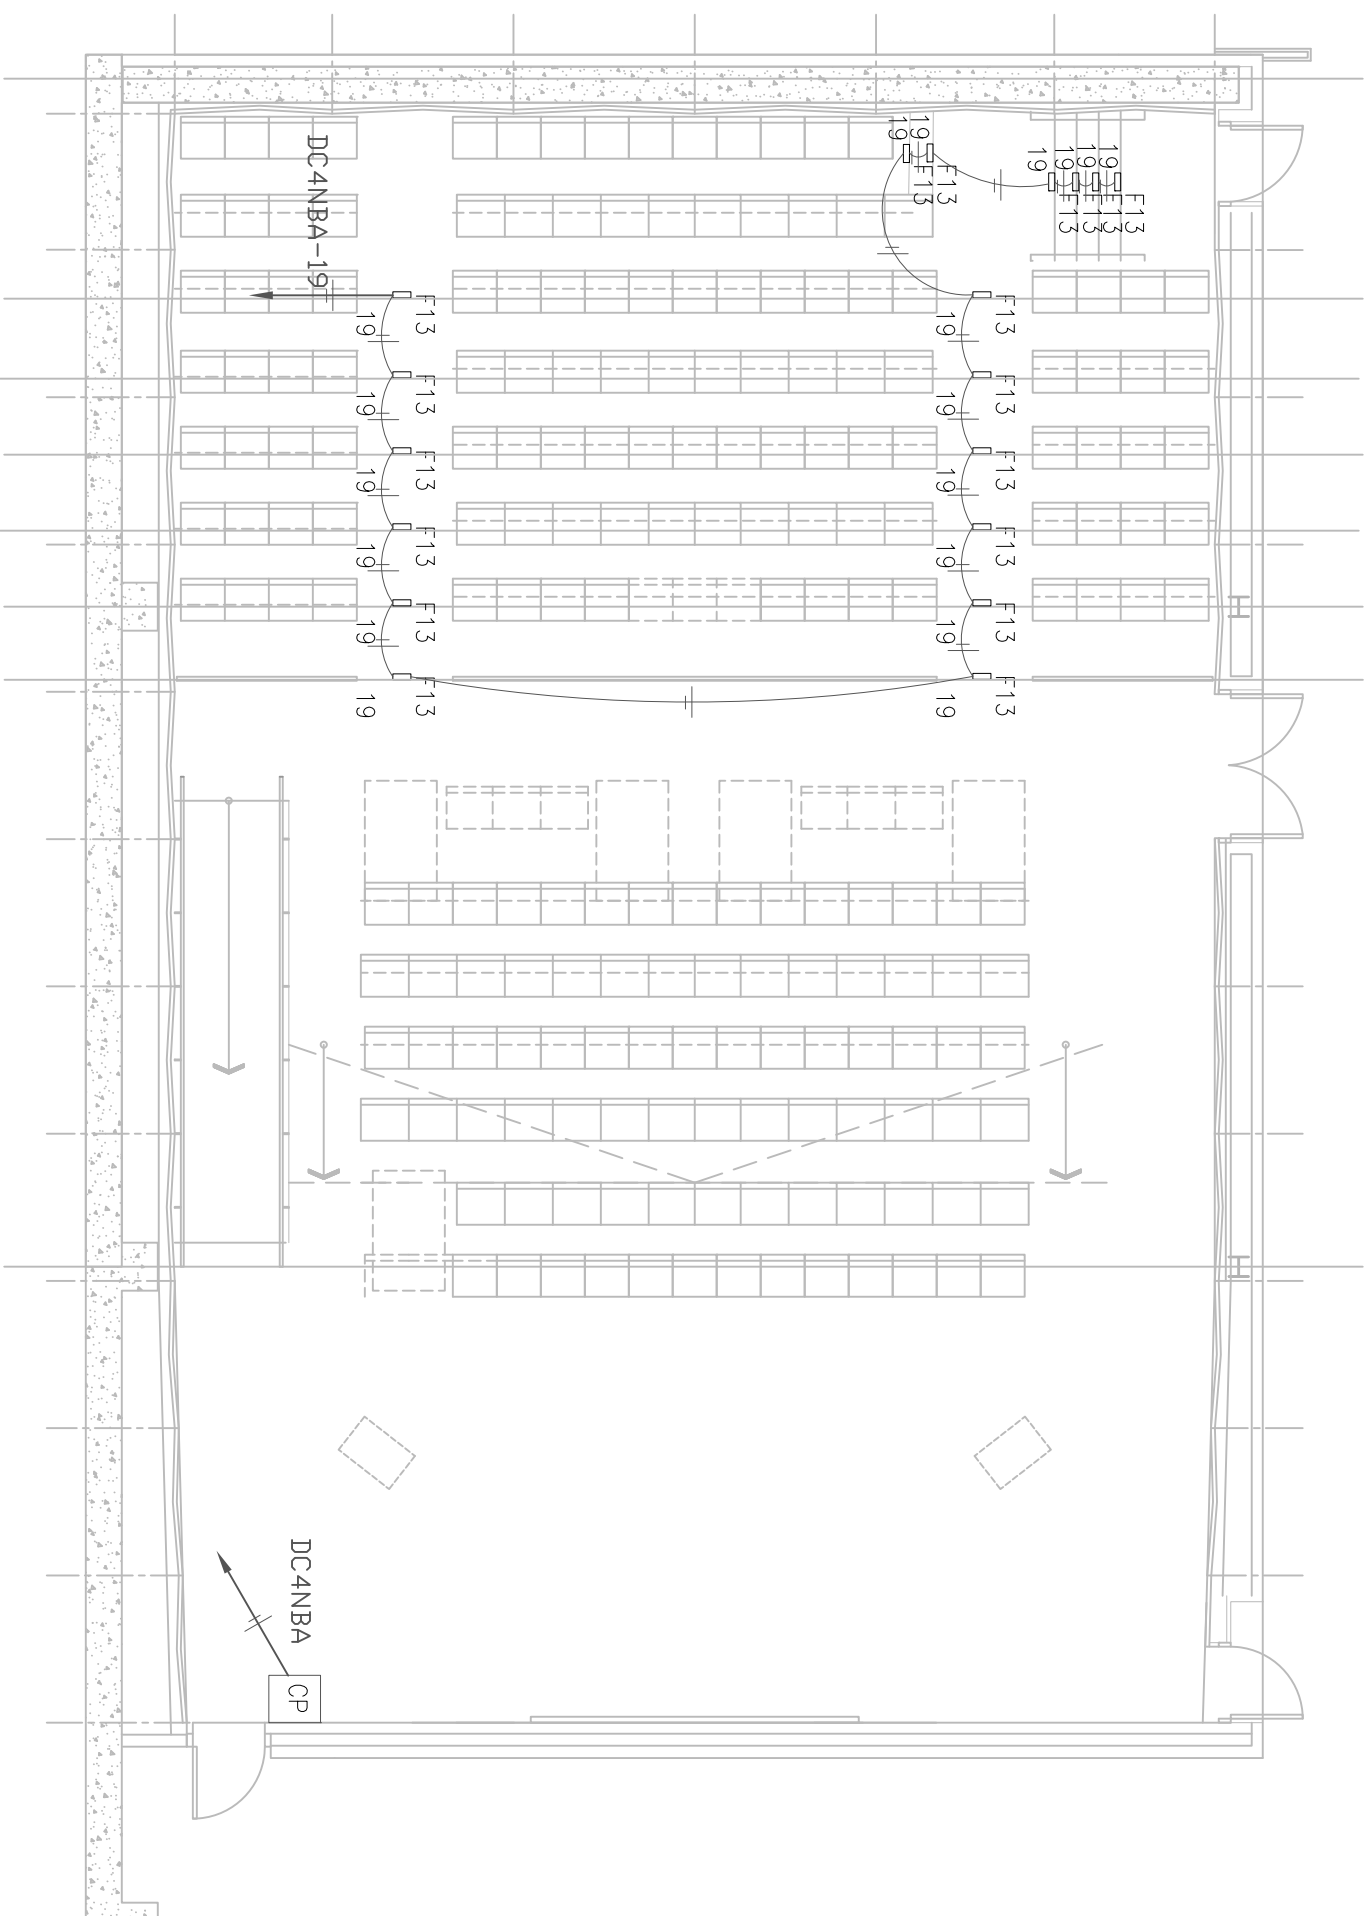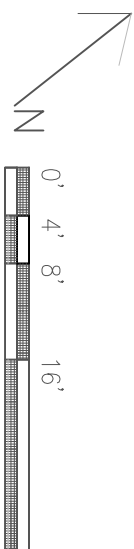


E3 ENLARGED FURNITURE PLAN
1/8" = 1'-0"

Meeting Room Electrical Plan

SCALE: 1/8"=1'0"

Massachusetts Public Library

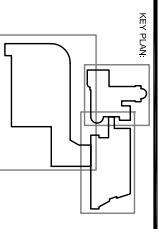

DRAWING TITLE
MEETING ROOM ELECTRICAL PLAN

DATE	REVISION

CHECKED BY: Paul Danvers


DRAWN BY: Melissa Gault

SCALE: 1/8"=1'0"


DATE:

DRAWING NUMBER:

E3-B

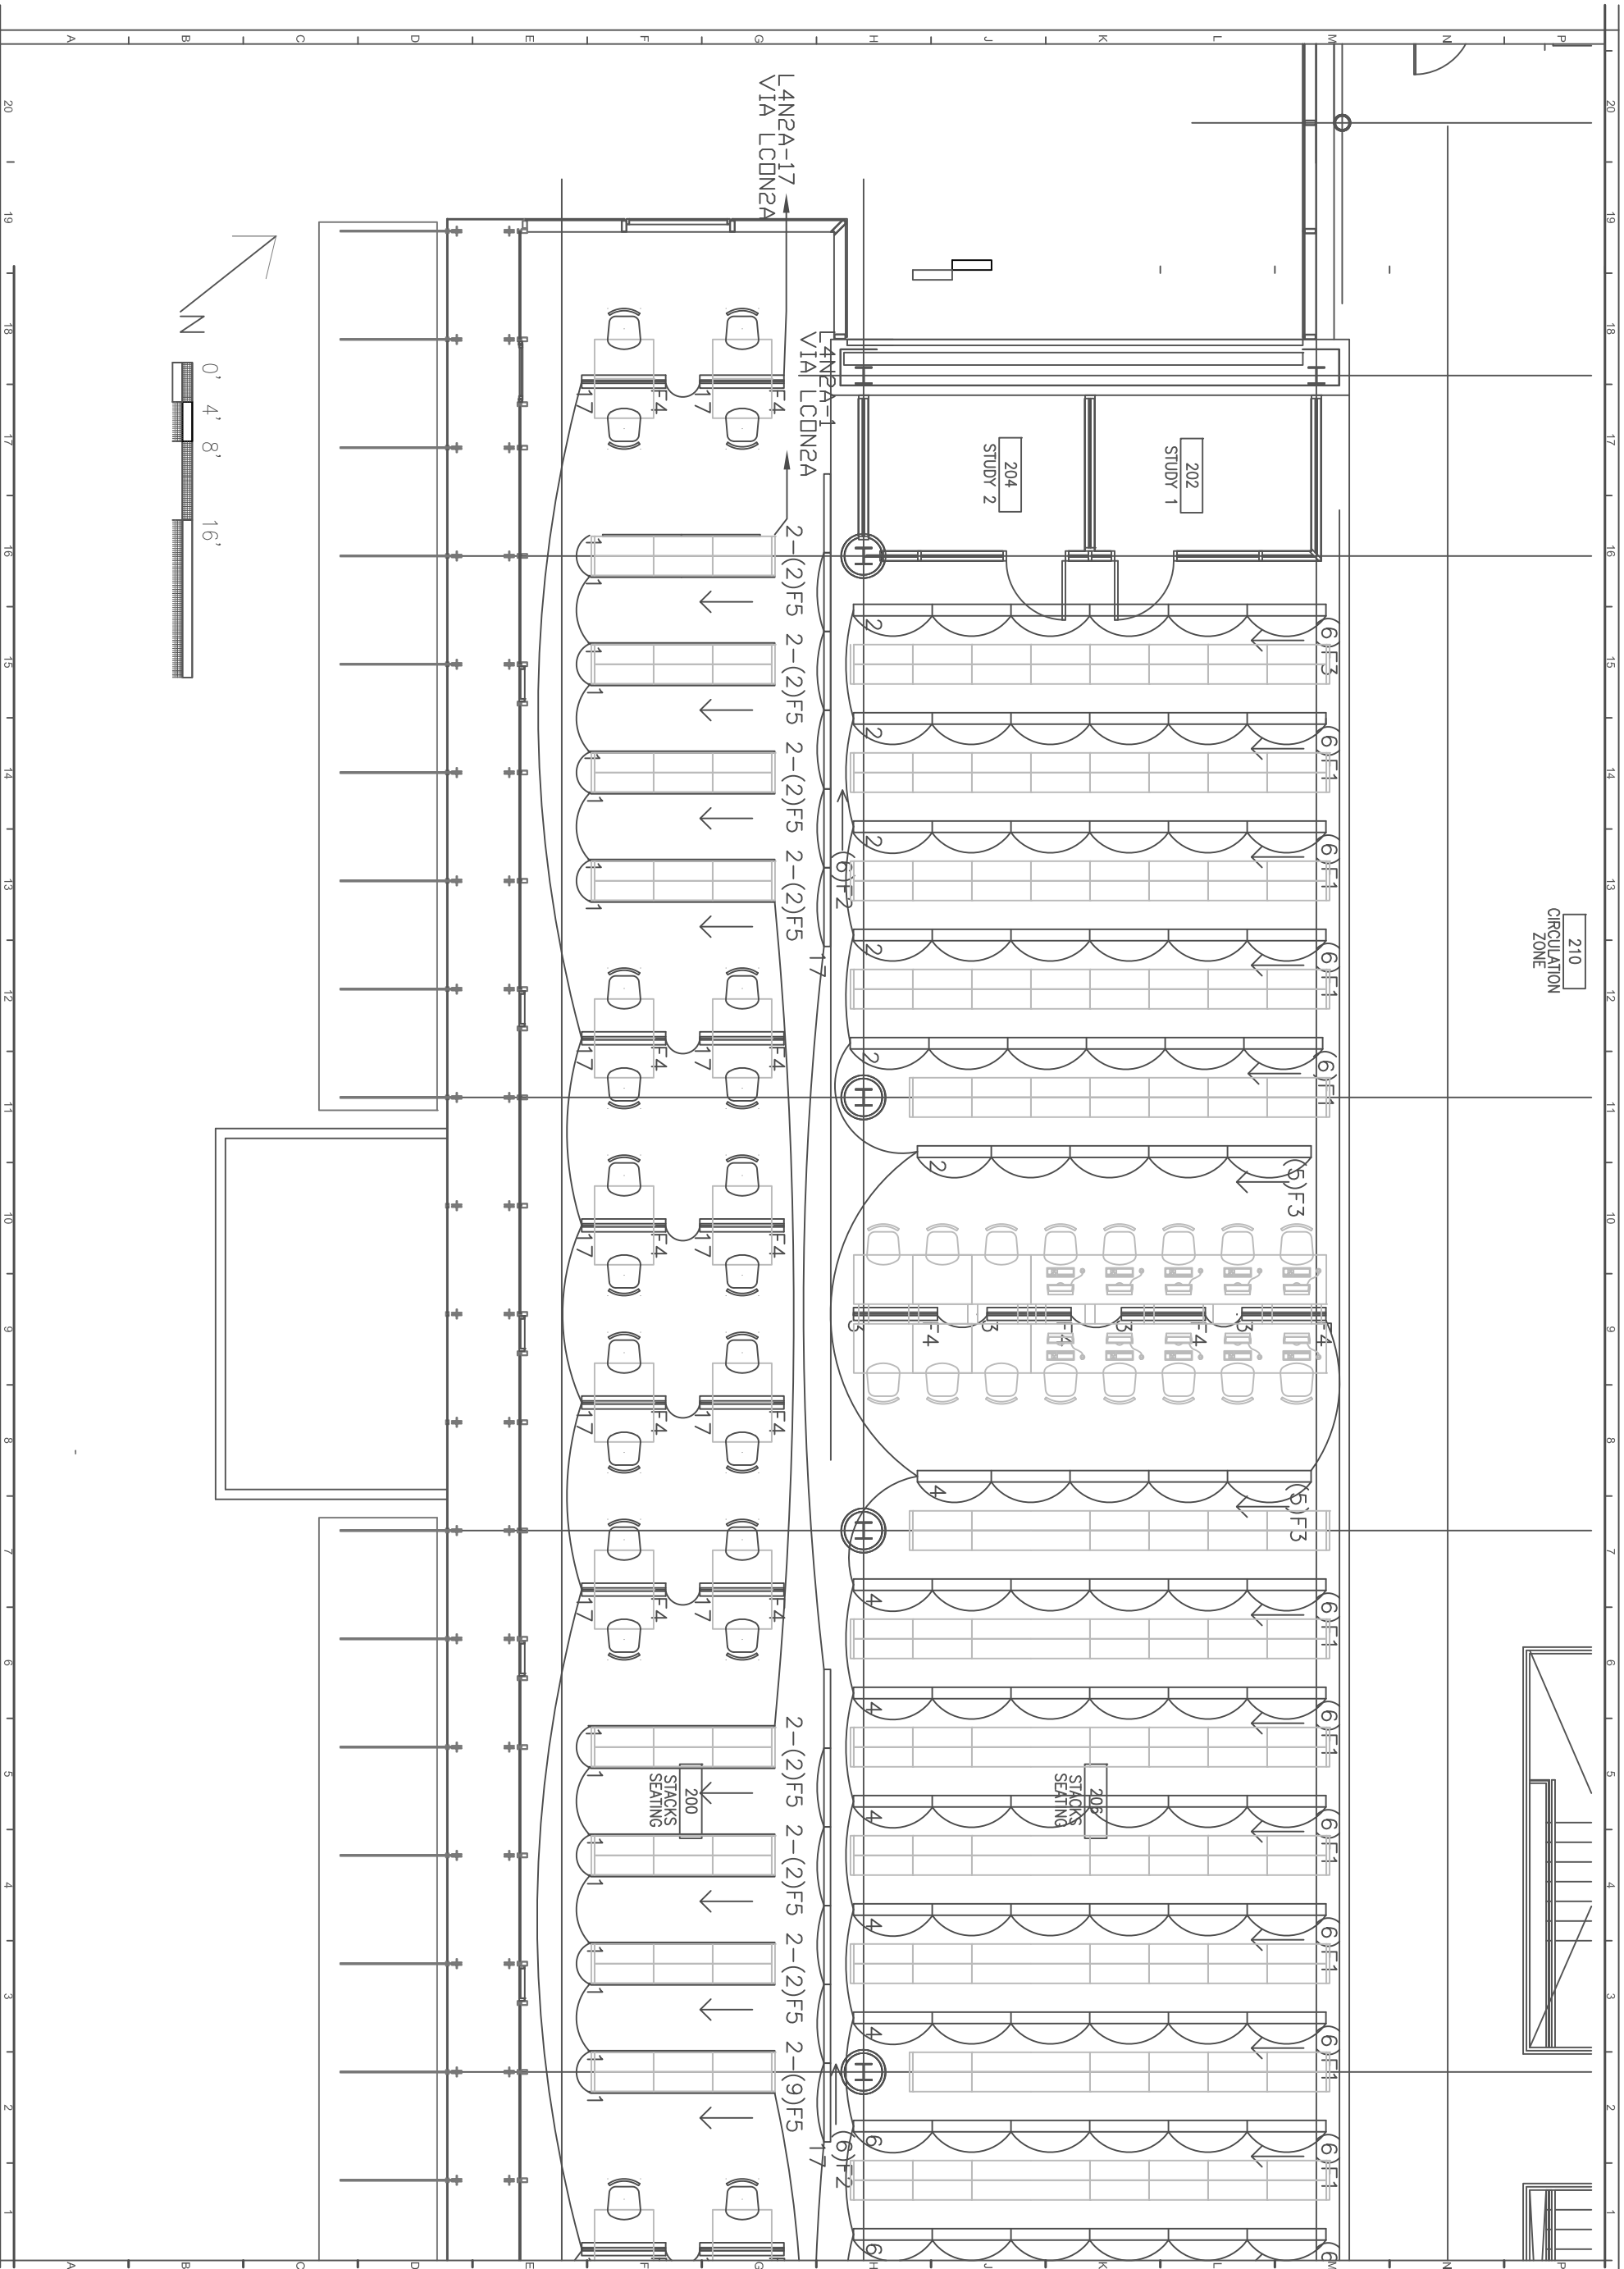

210
CIRCULATION
ZONE

 


MAIN LIBRARY
EXPANSION PROJECT

Massachusetts Public Library
Massachusetts

Stacks-Seating Area Electrical Plan

SCALE: 1/8"=1'0"

Massachusetts Public Library

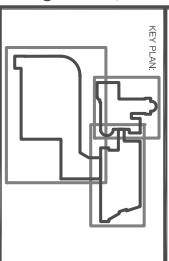

DRAWING TITLE: 2nd Floor Electrical Plan

DATE: REVISION


DRAWN BY: JMD
CHECKED BY: Paul Durwin

SCALE: 1/8"=1'0"

DUE DATE: 4/17/09

DRAWING NUMBER:

E4-A

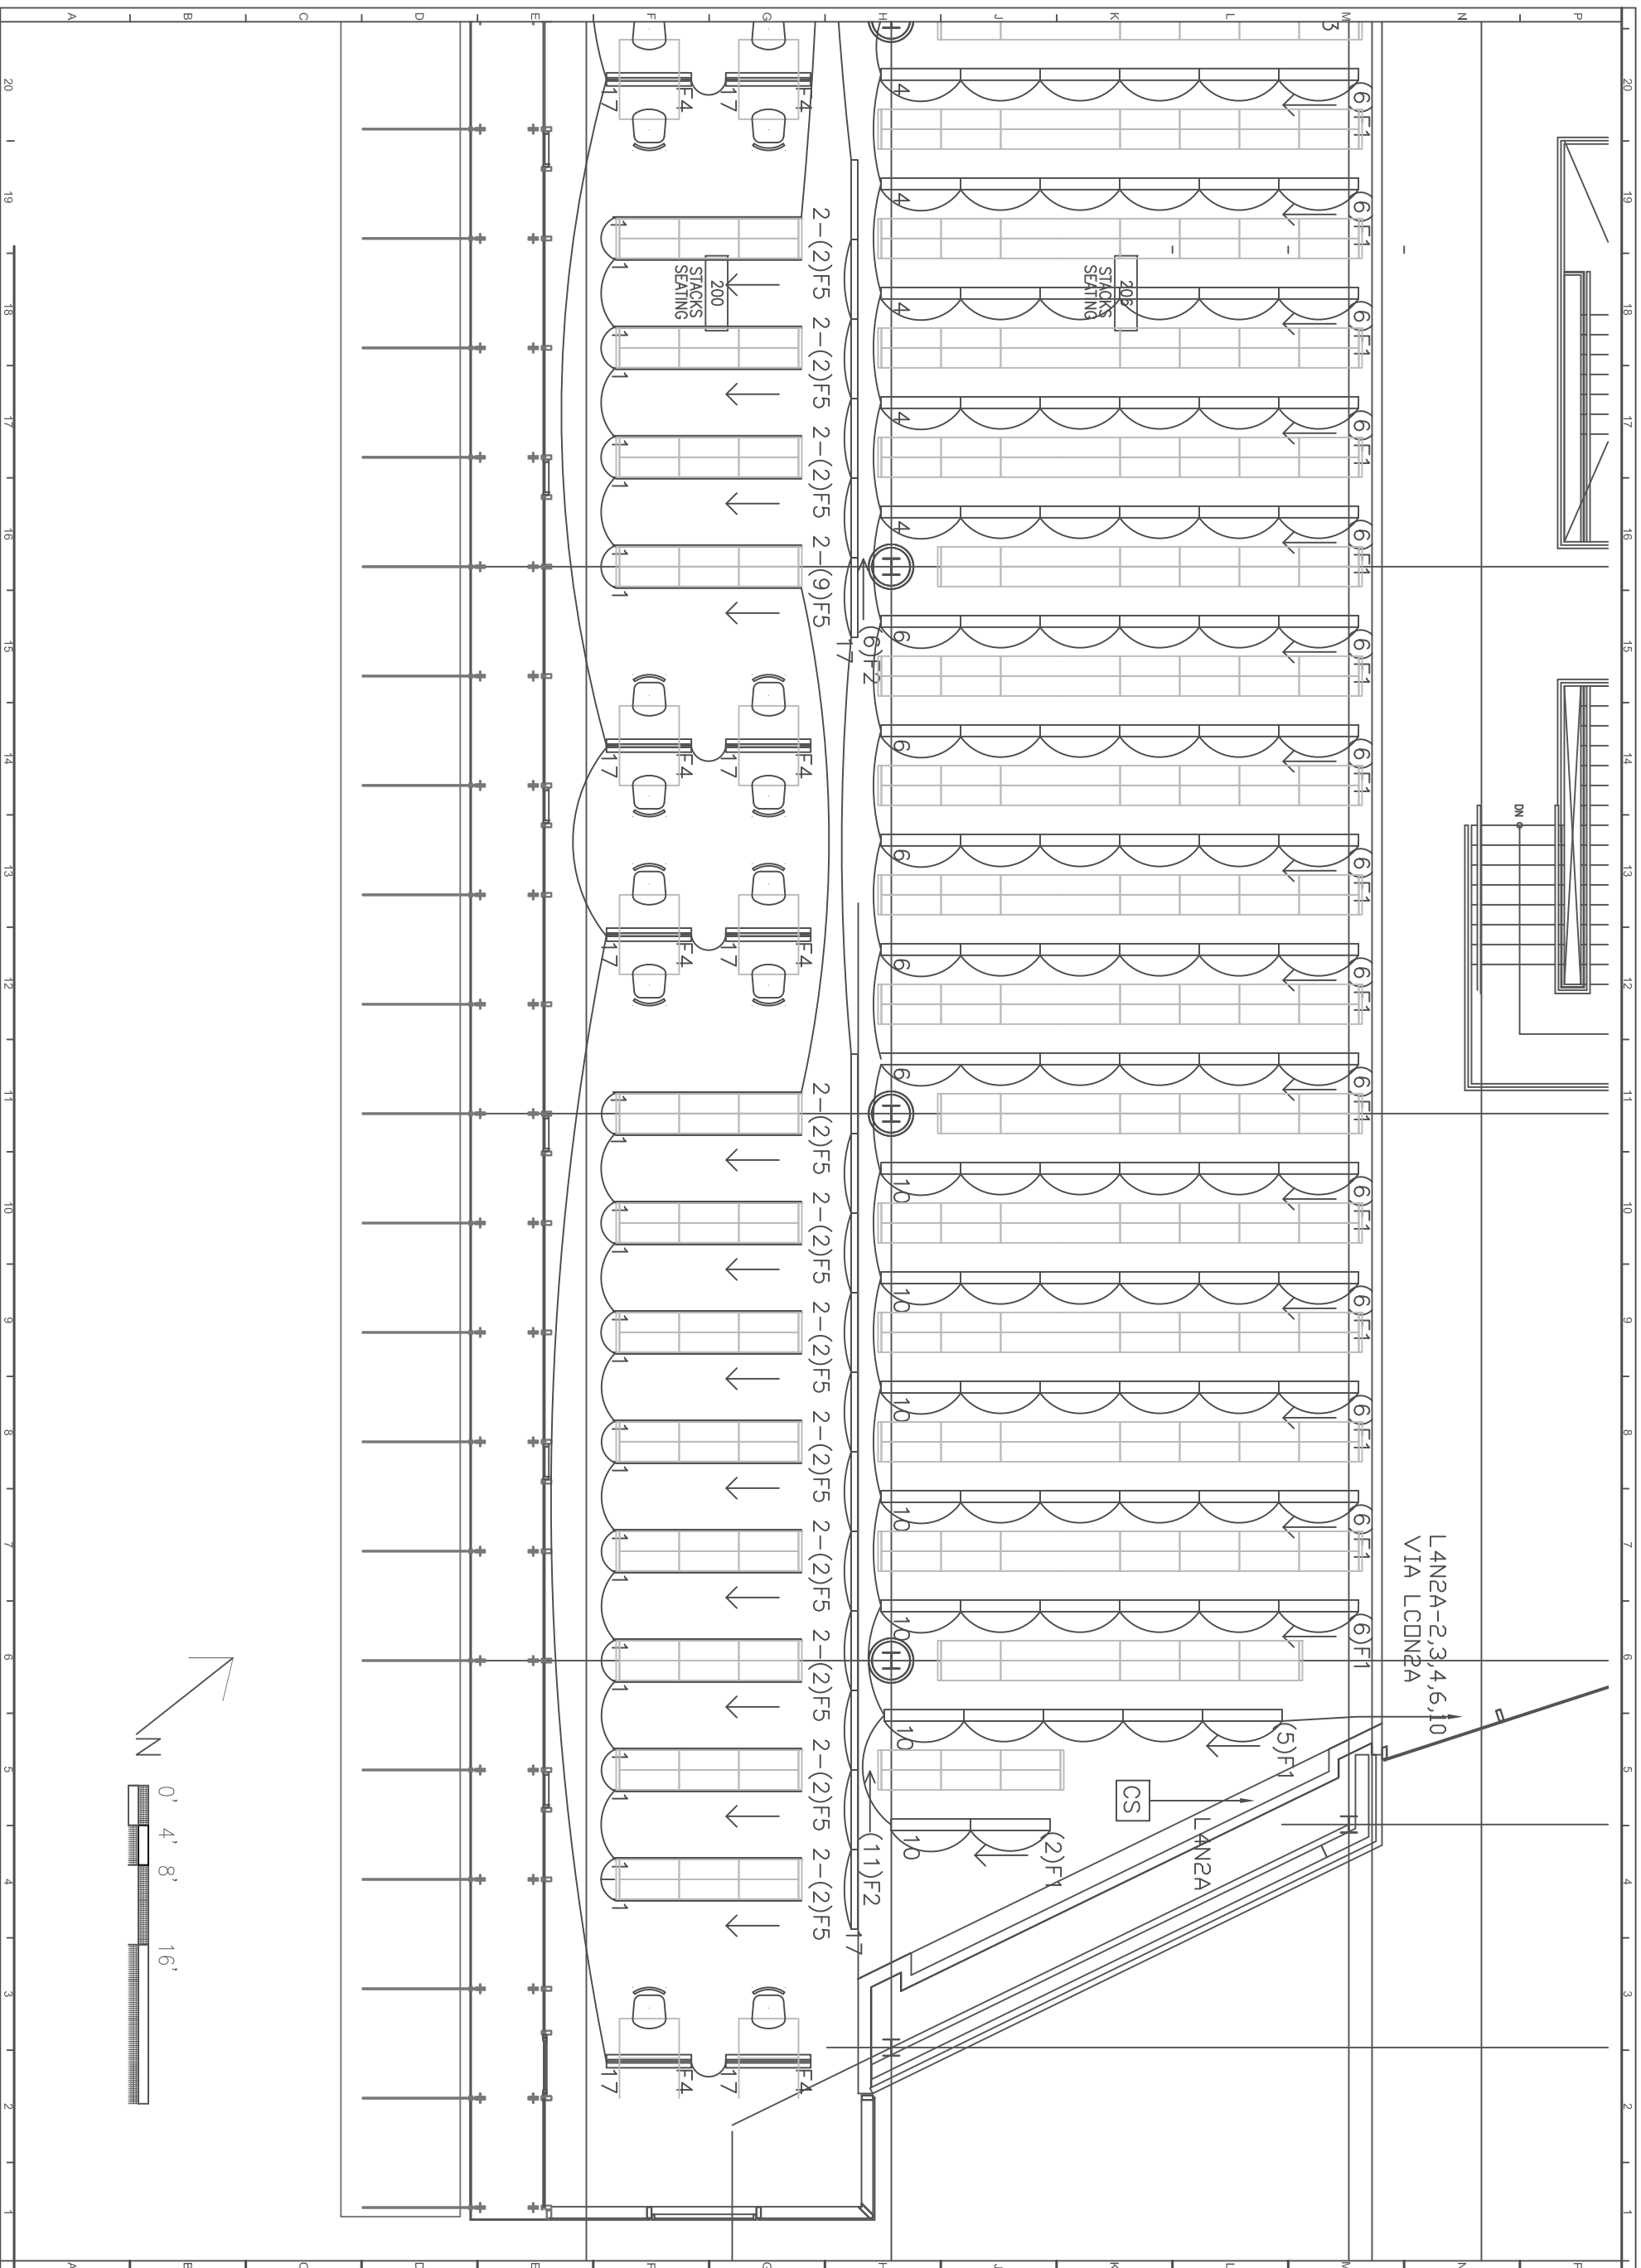


MAIN LIBRARY
EXPANSION PROJECT

Massachusetts Public Library
Massachusetts

Stacks-Seating Area Electrical Plan

SCALE: 1/8"=1'0"

Massachusetts Public Library

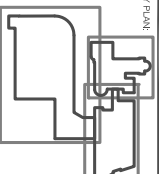

DRAWING TITLE: 2nd Floor Electrical Plan

DATE: REVISION

DRAWN BY: JM CHECKED BY: Prof. Durren

SCALE: 1/8"=1'0"

DWG DATE: 4/17/09

DRAWING NUMBER:

E4-B